

EXTERIOR FINISHES

	
BR-A BRICK VENEER COLOR: DARK BROWN SIZE: MODULAR	EC-1 PREFINISHED METAL COPING COLOR: DARK BRONZE
	
BR-B BRICK VENEER COLOR: LIGHT BROWN SIZE: MODULAR	ET-13 EXTERIOR PAINT COLOR: DARK BRONZE FINISH: SEMI-GLOSS
	
	ST-1 STOREFRONT COLOR: DARK BRONZE

ATTACHED CANOPY SCHEDULE

Mark	Description	Count	Overall Width	Overall Depth	Tie Back Mounting (Offset From Top)	Integral Lighting
C1-C	Exterior Canopy	13	6'-4"	1'-0"	0"	No
C4-B	Exterior Canopy	1	5'-4"	4'-0"	2'-4"	Yes
C4-G	Exterior Canopy	1	7'-0"	4'-0"	2'-4"	Yes
C5-A	Exterior Canopy	1	10'-0"	5'-0"	2'-4"	Yes
Grand total		16				



PERSPECTIVE VIEW - FRONT RIGHT



PERSPECTIVE VIEW - REAR LEFT



PERSPECTIVE VIEW - REAR RIGHT



PERSPECTIVE VIEW - FRONT LEFT



EXTERIOR ELEVATION
1" = 10'-0"


 


EXTERIOR ELEVATION
1" = 10'-0"



PERSPECTIVE VIEW

OP CANOPY FINISHES

	SP-1 PREFINISHED METAL COLOR: DARK BRONZE
	SP-2 METAL DECKING COLOR: WHITE



EXTERIOR ELEVATION
1" = 10'-0"




EXTERIOR ELEVATION
1" = 10'-0"



PERSPECTIVE VIEW - PATIO

PATIO SEATING SCHEDULE

Mark	Type	Count	Manufacturer	Model	Width	Depth	Height	Material	Finish
1	Patio Chair	28	Benchmark Design Group	BAJA SIDE STACK (2012)	3'-0"	3'-0"	2'-5 1/4"	Aluminum - Dark Bronze	RAL 49/66220 (C34 Bronze One Coat)
2	Patio Table - 4 Top	2	Benchmark Design Group	TAB3055-3636-AAL-WJ-UH-BDT	3'-0"	3'-0"	2'-5 1/4"	Aluminum - Dark Bronze	RAL 49/66220 (C34 Bronze One Coat)
3	Patio Table - 4 Top - ADA	3	Benchmark Design Group	TAB3055-3644-AAL-WJ-UH-BDT	3'-8"	3'-0"	2'-5 1/4"	Aluminum - Dark Bronze	RAL 49/66220 (C34 Bronze One Coat)
4	Patio Table - 2 Top	4	Benchmark Design Group	TAB3055-2424-AAL-WJ-BDT	2'-0"	2'-0"	2'-5 1/4"	Aluminum - Dark Bronze	RAL 49/66220 (C34 Bronze One Coat)
5	Patio Umbrella	5	Tuuci	OCEAN MASTER PARASOL	2'-0"	2'-0"	3'-11"	Dark Bronze	RAL 49/66220 (C34 Bronze One Coat)
6	Trash Receptacle	2	Benchmark Design Group	CFA-AL-2444	2'-0"	2'-0"	3'-11"	Dark Bronze	RAL 49/66220 (C34 Bronze One Coat)
8	Bike Rack - Surface Mount	2	Belson Outdoors	ORN-2-SF-P	3'-4"	2 3/8"	2'-9"	Steel	Black Powder Coated

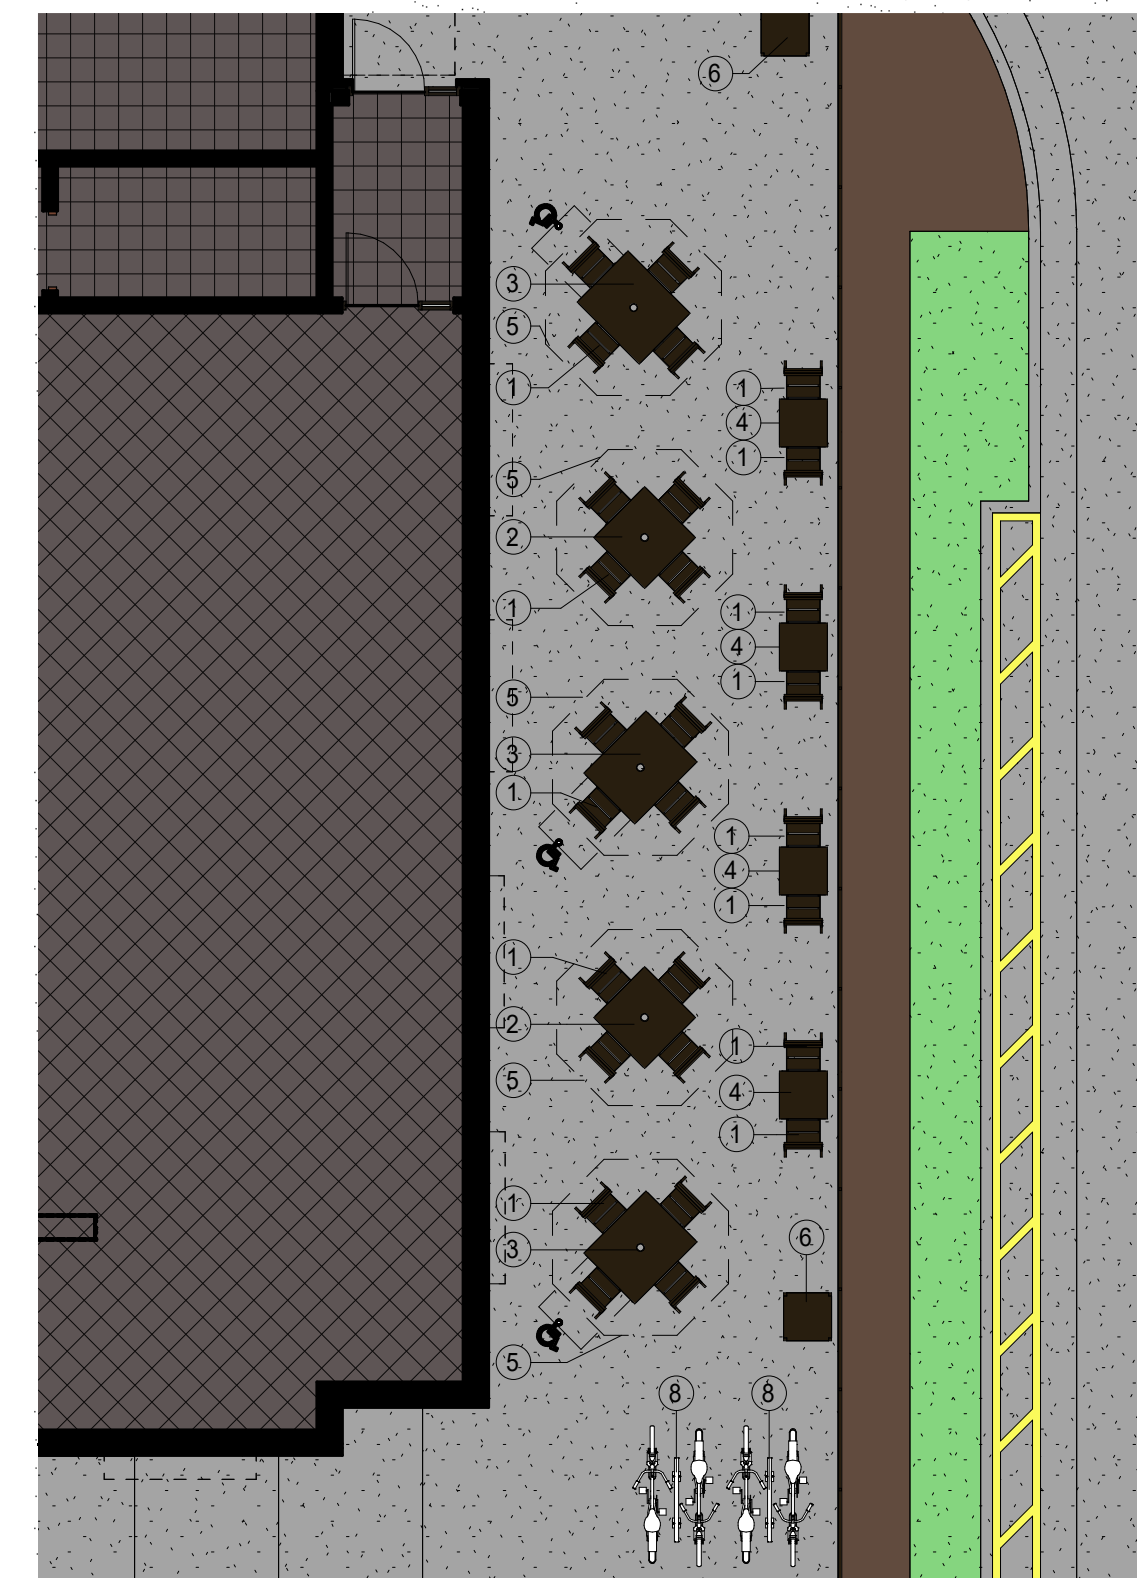

DINING PATIO PLAN
1/8" = 1'-0"

CODE COMPLIANCE CHART

- THIS BUILDING HAS BEEN DESIGNED IN ACCORDANCE WITH THE FOLLOWING:

- 2015 MICHIGAN BUILDING CODE
- 2015 INTERNATIONAL FIRE CODE
- 2018 MICHIGAN PLUMBING CODE
- 2015 MICHIGAN MECHANICAL CODE
- 2017 NATIONAL ELECTRIC CODE WITH STATE AMENDMENTS (PART 8)
- 2015 MICHIGAN ENERGY CODE
- 2009 ICC/ANSI A117.1 ACCESSIBLE AND USABLE BUILDINGS AND FACILITIES
- 2010 NFPA 13 FIRE SUPPRESSION
- 2010 NFPA 72 FIRE ALARM

- USE GROUP = A2
- CONSTRUCTION CLASSIFICATION TYPE = VB
- ALLOWABLE BUILDING HEIGHT = 60'-0"
- ACTUAL BUILDING HEIGHT = 21'-4"
- ALLOWABLE NUMBER OF STORIES = 2
- ACTUAL NUMBER OF STORIES = 1
- ALLOWABLE BUILDING AREA = 24,000 SF
- ACTUAL BUILDING AREA = 8,279 SF
- FIRE SUPPRESSION SYSTEM = YES (FULL AUTOMATIC SPRINKLER SYSTEM)
- SEE SITE PLAN FOR LOCATION OF FDC
- FIRE ALARM SYSTEM = YES (FULL FIRE ALARM SYSTEM)



Chick-fil-A

Chick-fil-A
5200 Buffington Road
Atlanta, Georgia
30349-2998

PROTOTYPICAL SET

NOT FOR REGULATORY APPROVAL, BIDDING, OR CONSTRUCTION

CHICK-FIL-A
Rochester Hills
3178 & 3200 South Rochester Rd
Rochester Hills, MI

FSR#0000

BUILDING TYPE / SIZE: P13 SE
RELEASE: 5/20/21

REVISION SCHEDULE

NO.	DATE	DESCRIPTION

CONSULTANT PROJECT #
PRINTED FOR: REVIEW
DATE: 5/20/21
DRAWN BY: ER

Information contained on this drawing and in all digital files produced for above named project may not be reproduced in any manner without express written or verbal consent from authorized project representatives.

DESIGN DEVELOPMENT

SHEET NUMBER

X-900