

Approved
City of Rochester Hills
 Planning & Economic Development
 Date: 10-6-21

Luminaire Schedule		Label	Arrangement	LLF	MH	Tilt
Symbol	Qty	Tag		0.950	20'	45°
	5	P5	SINGLE-TILT45			
	3	P6	BACK-BACK-TILT45	0.950	20'	45°

Calculation Summary						
Label	Workplane	Avg	Max	Min	Avg/Min	Max/Min
Site	At Grade	0.41	10.8	0.0	N.A.	N.A.
Vertical @ 5ft	Vertical Facing In @ 5' AFG	0.15	0.5	0.0	N.A.	N.A.
Bottom Lot	At Grade	0.90	6.1	0.0	N.A.	N.A.
Hotel Parking	At Grade	0.01	0.1	0.0	N.A.	N.A.
Top Lot	At Grade	1.09	10.8	0.1	10.90	108.00

GATEWAY II

STERLING HEIGHTS, MI

Drawn By: DGafford

Checked By: JKnepp

Date: 10/6/2021


Scale: 1" = 60'



Version #5

Page 1 of 2

*Area that falls below 0.1fc highlighted in blue.
 **Pink grid is vertical grid @ 5' AFG facing in.
 ***Rotated P6 90°.

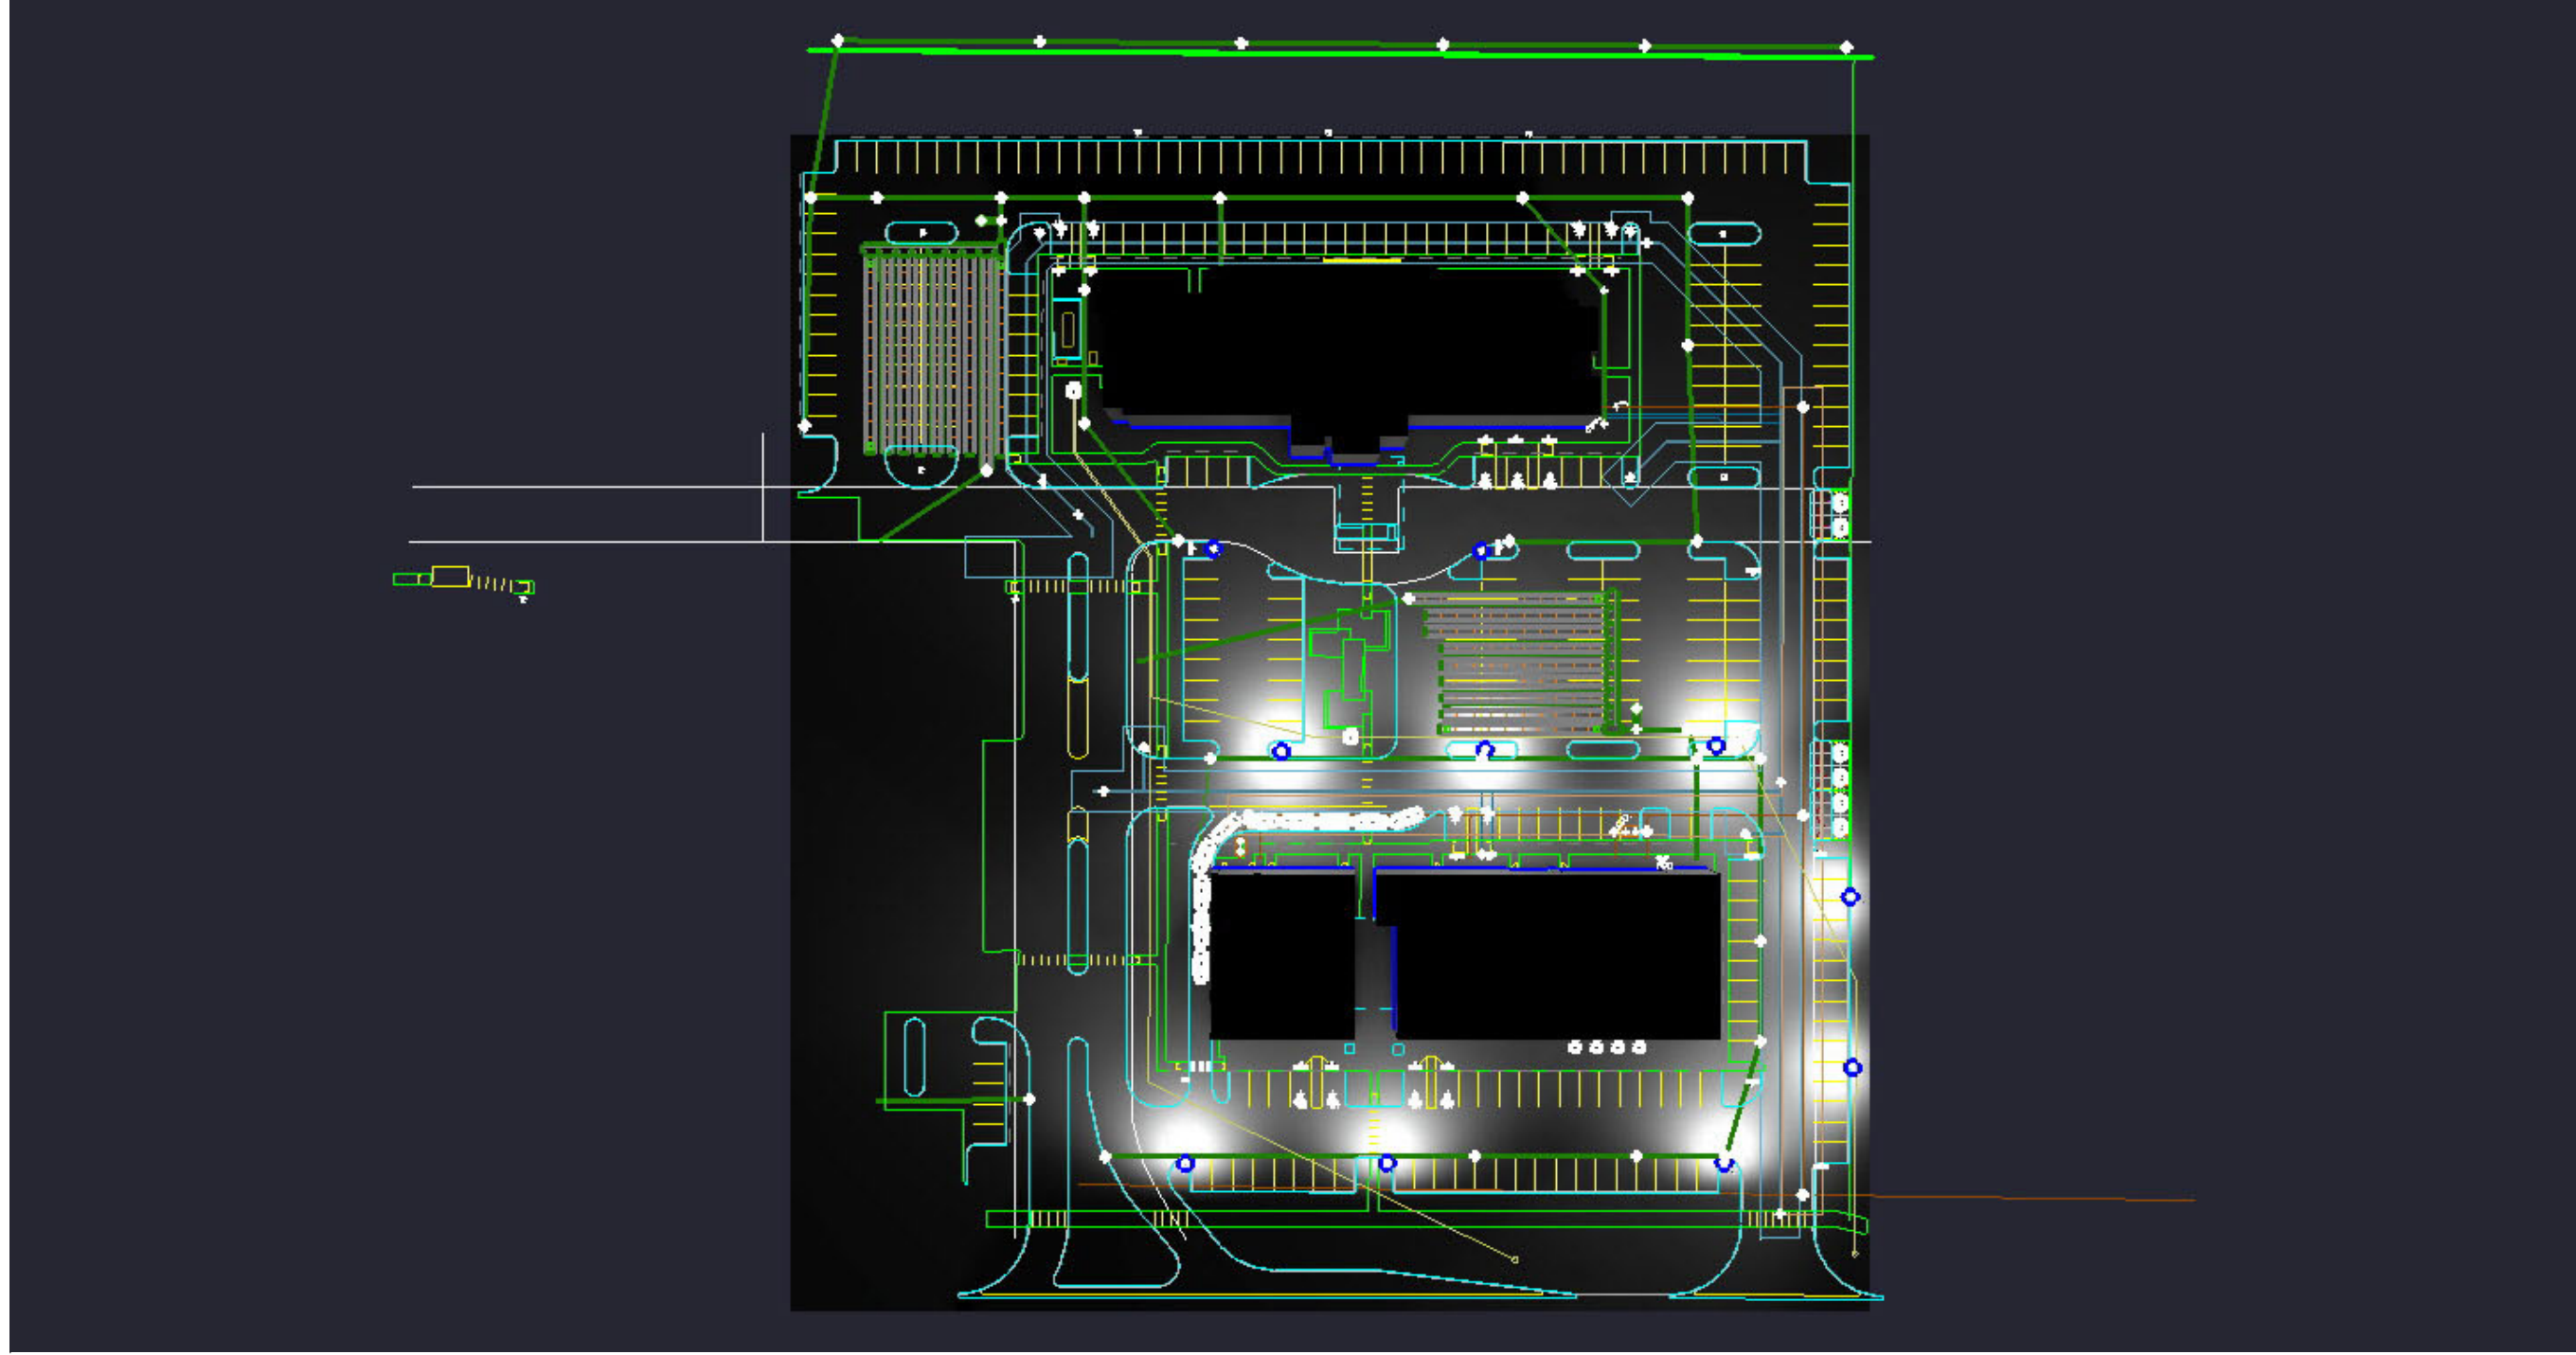

GATEWAY II

STERLING HEIGHTS, MI

Version #5

Page 2 of 2

Drawn By: DGafford

Checked By: JKnepp

Date: 10/6/2021

Scale: Not to Scale

