

Plan View  
Scale 1" = 40'




**NOTES**

1. Crosswalk calculations grids run length of crosswalk and measured from grade level to 6'-0" in height.
2. All measured crosswalk calculations face the flow of traffic.

STATISTICS						
Description	Symbol	Avg	Max	Min	Max/Min	Avg/Min
Crosswalk #1	+	1.5 fc	2.5 fc	1.0 fc	2.5:1	1.5:1
Crosswalk #2	+	0.4 fc	0.5 fc	0.3 fc	1.7:1	1.3:1
Crosswalk #3	+	2.6 fc	4.3 fc	1.6 fc	2.7:1	1.6:1
Crosswalk #4	+	2.6 fc	3.3 fc	1.6 fc	2.1:1	1.6:1
Crosswalk #5	+	0.3 fc	0.5 fc	0.2 fc	2.5:1	1.5:1
Crosswalk #6	+	1.5 fc	2.5 fc	1.0 fc	2.5:1	1.5:1
Crosswalk #7	+	2.4 fc	3.0 fc	1.5 fc	2.0:1	1.6:1
Crosswalk #8	+	0.4 fc	0.6 fc	0.2 fc	3.0:1	2.0:1
Crosswalk #9	+	1.7 fc	2.8 fc	1.1 fc	2.5:1	1.5:1
Crosswalk #10	+	2.5 fc	3.2 fc	1.6 fc	2.0:1	1.6:1
Crosswalk #11	+	0.3 fc	0.5 fc	0.2 fc	2.5:1	1.5:1
Crosswalk #12	+	2.7 fc	3.1 fc	1.9 fc	1.6:1	1.4:1
Crosswalks - Combined Stats	+	1.5 fc	4.3 fc	0.2 fc	21.5:1	7.7:1
Hamlin Road Roundabout	+	2.3 fc	3.8 fc	0.5 fc	7.6:1	4.6:1
NE Sidewalk	■	1.0 fc	2.0 fc	0.1 fc	20.0:1	10.0:1
NW Sidewalk	×	1.1 fc	1.9 fc	0.4 fc	4.8:1	2.8:1
SE Sidewalk	○	1.0 fc	1.9 fc	0.2 fc	9.5:1	5.0:1
SW Sidewalk	□	0.7 fc	2.0 fc	0.1 fc	20.0:1	7.0:1

LUMINAIRE SCHEDULE							
Symbol	Label	Qty	Catalog Number	Description	Lamp	File	Lumens LLF Watts
•	A	9	ESU250HP00X4	ESPLANADE	250W CLEAR HPS	47247.IES	29000 0.81 250
•	B	6	ESU250HP00X4	ESPLANADE	250W CLEAR HPS	47247.IES	29000 0.81 500

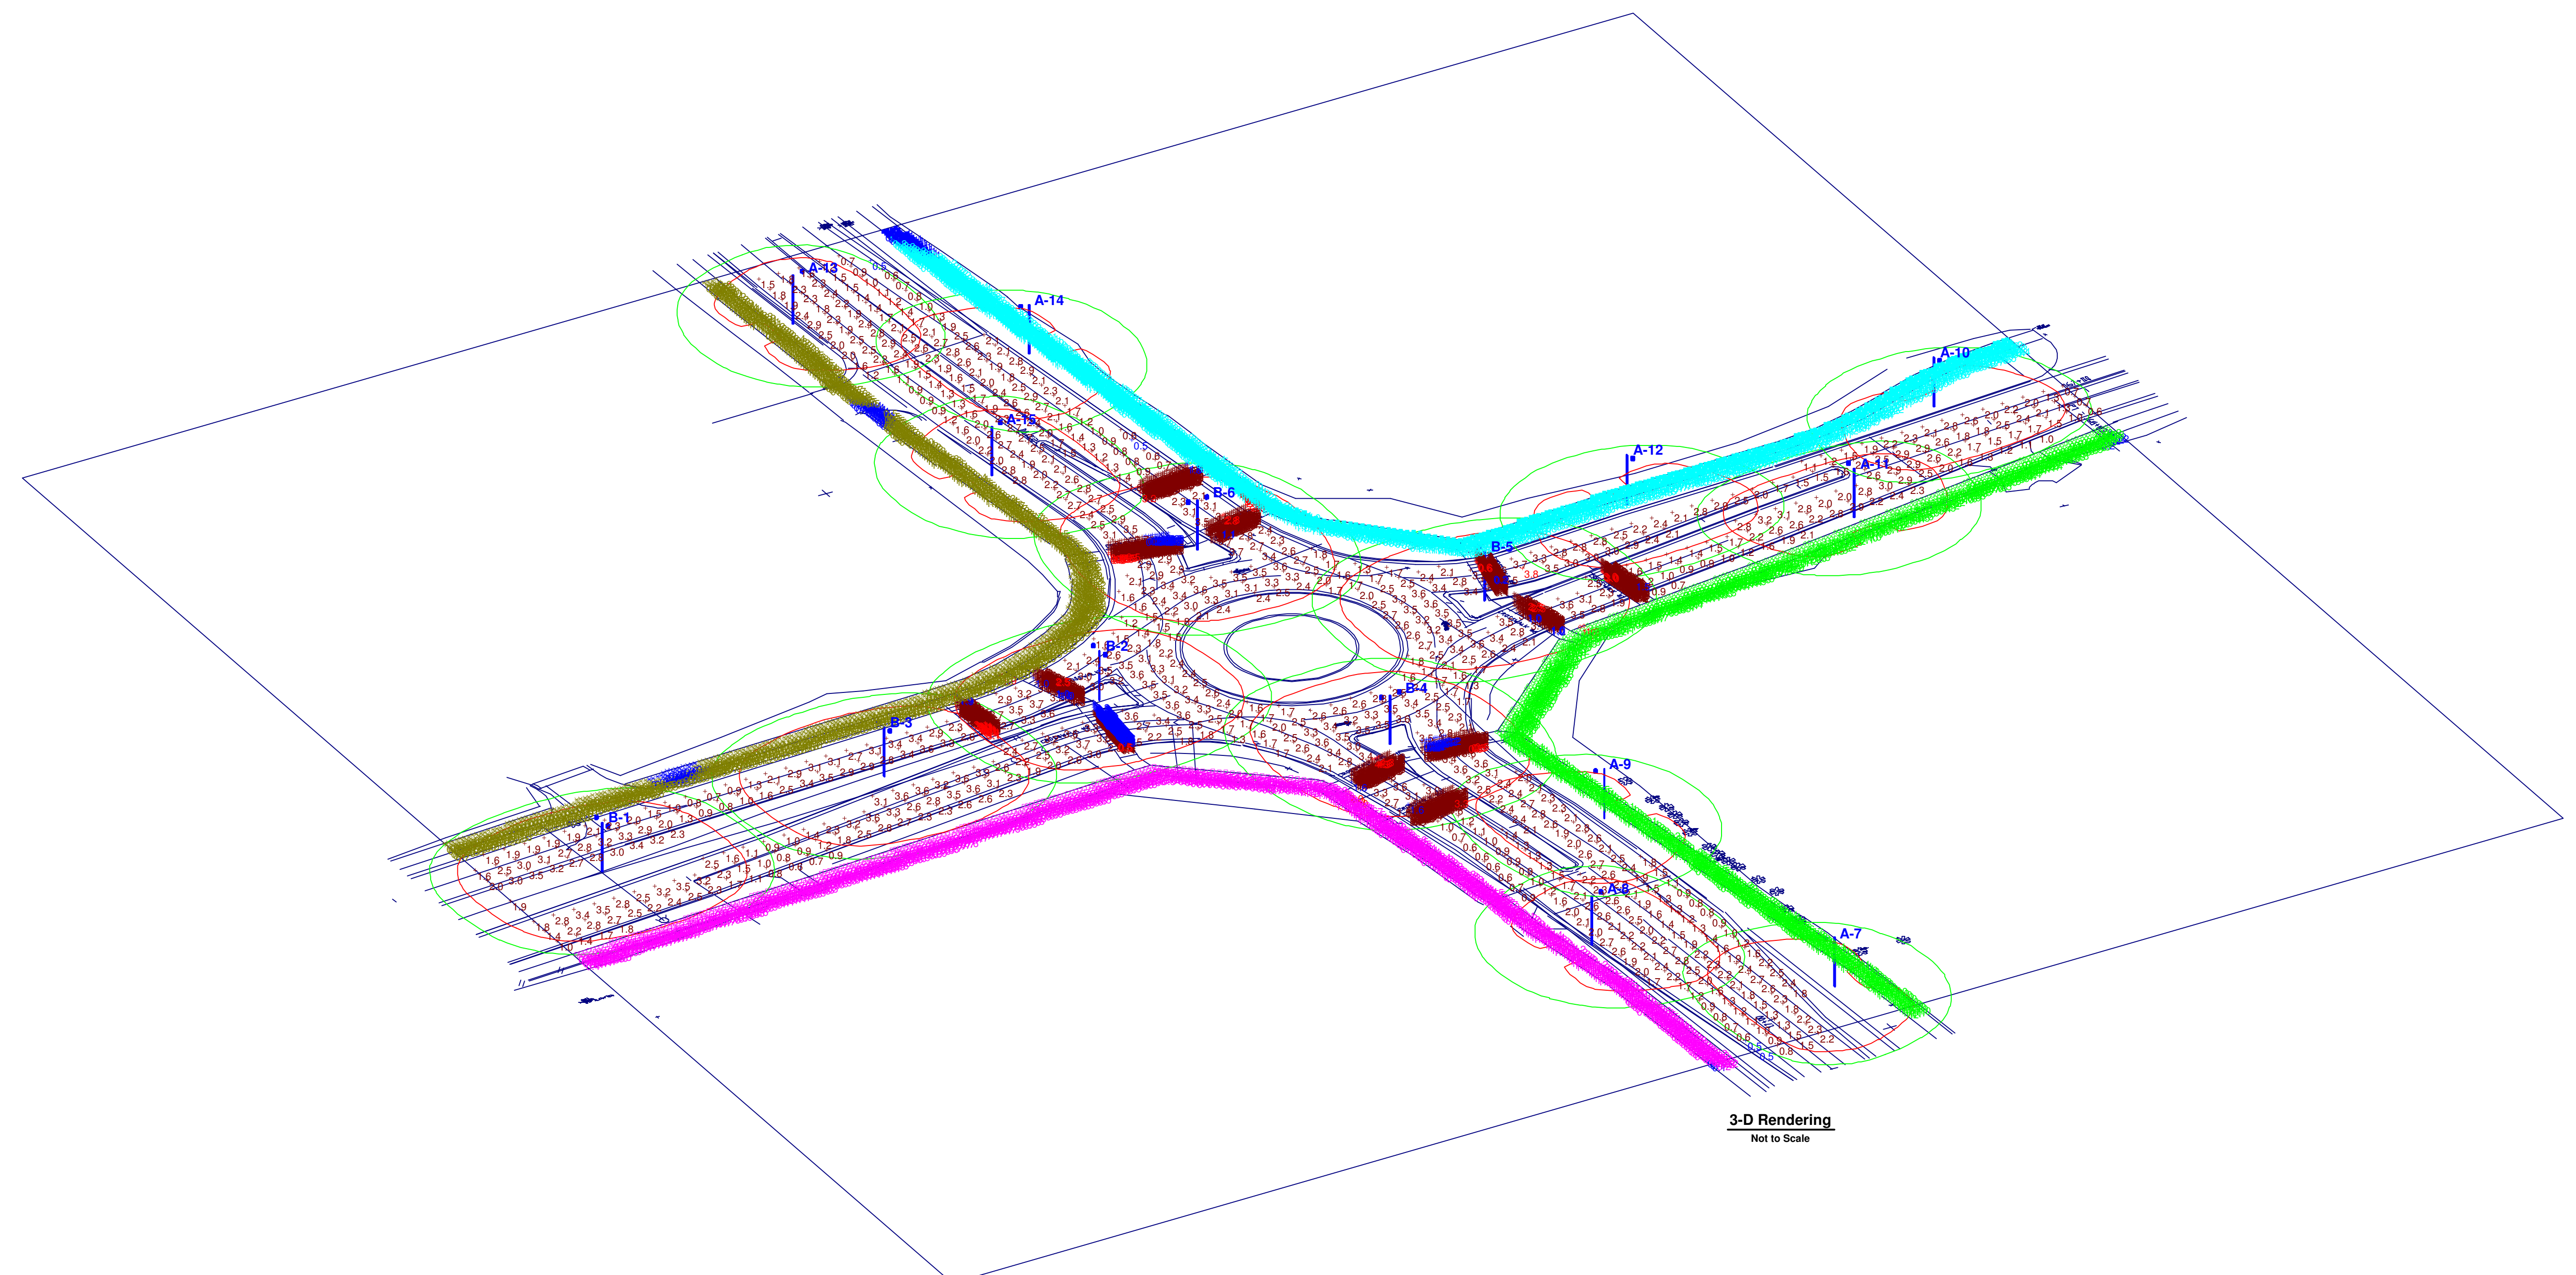

3-D Rendering  
Not to Scale